


1 FRONT ELEVATION  
SCALE 1/4"=1'-0"

2 LEFT SIDE ELEVATION  
SCALE 1/4"=1'-0"


DATE	REVISIONS	BY
		
<b>PROJECT</b> <b>SINGLE FAMILY HOUSE</b> JACOB WAY BLOCK 2, LOT # 22.14 LOPATCONG TWP., WARREN COUNTY, NJ NEW CONSTRUCTION "SCENIC RIDGE"		
DRAWING/S FRONT AND LEFT ELEVATIONS		
DATE: 03/11/19	SCALE: AS NOTED	
COMM.# 19S13e-6sA-u	DRAWN BY: S.B.	
GROUP - R-5	APPROVED: Y.I.W.	
CONST. TYPE - V-B		
YUVAL WELLSCH ARCH. NJ LIC. AI 14910	SEAL	SHEET NO. <b>A1</b>




1 REAR ELEVATION  
A-2  
SCALE 1/4"=1'-0"

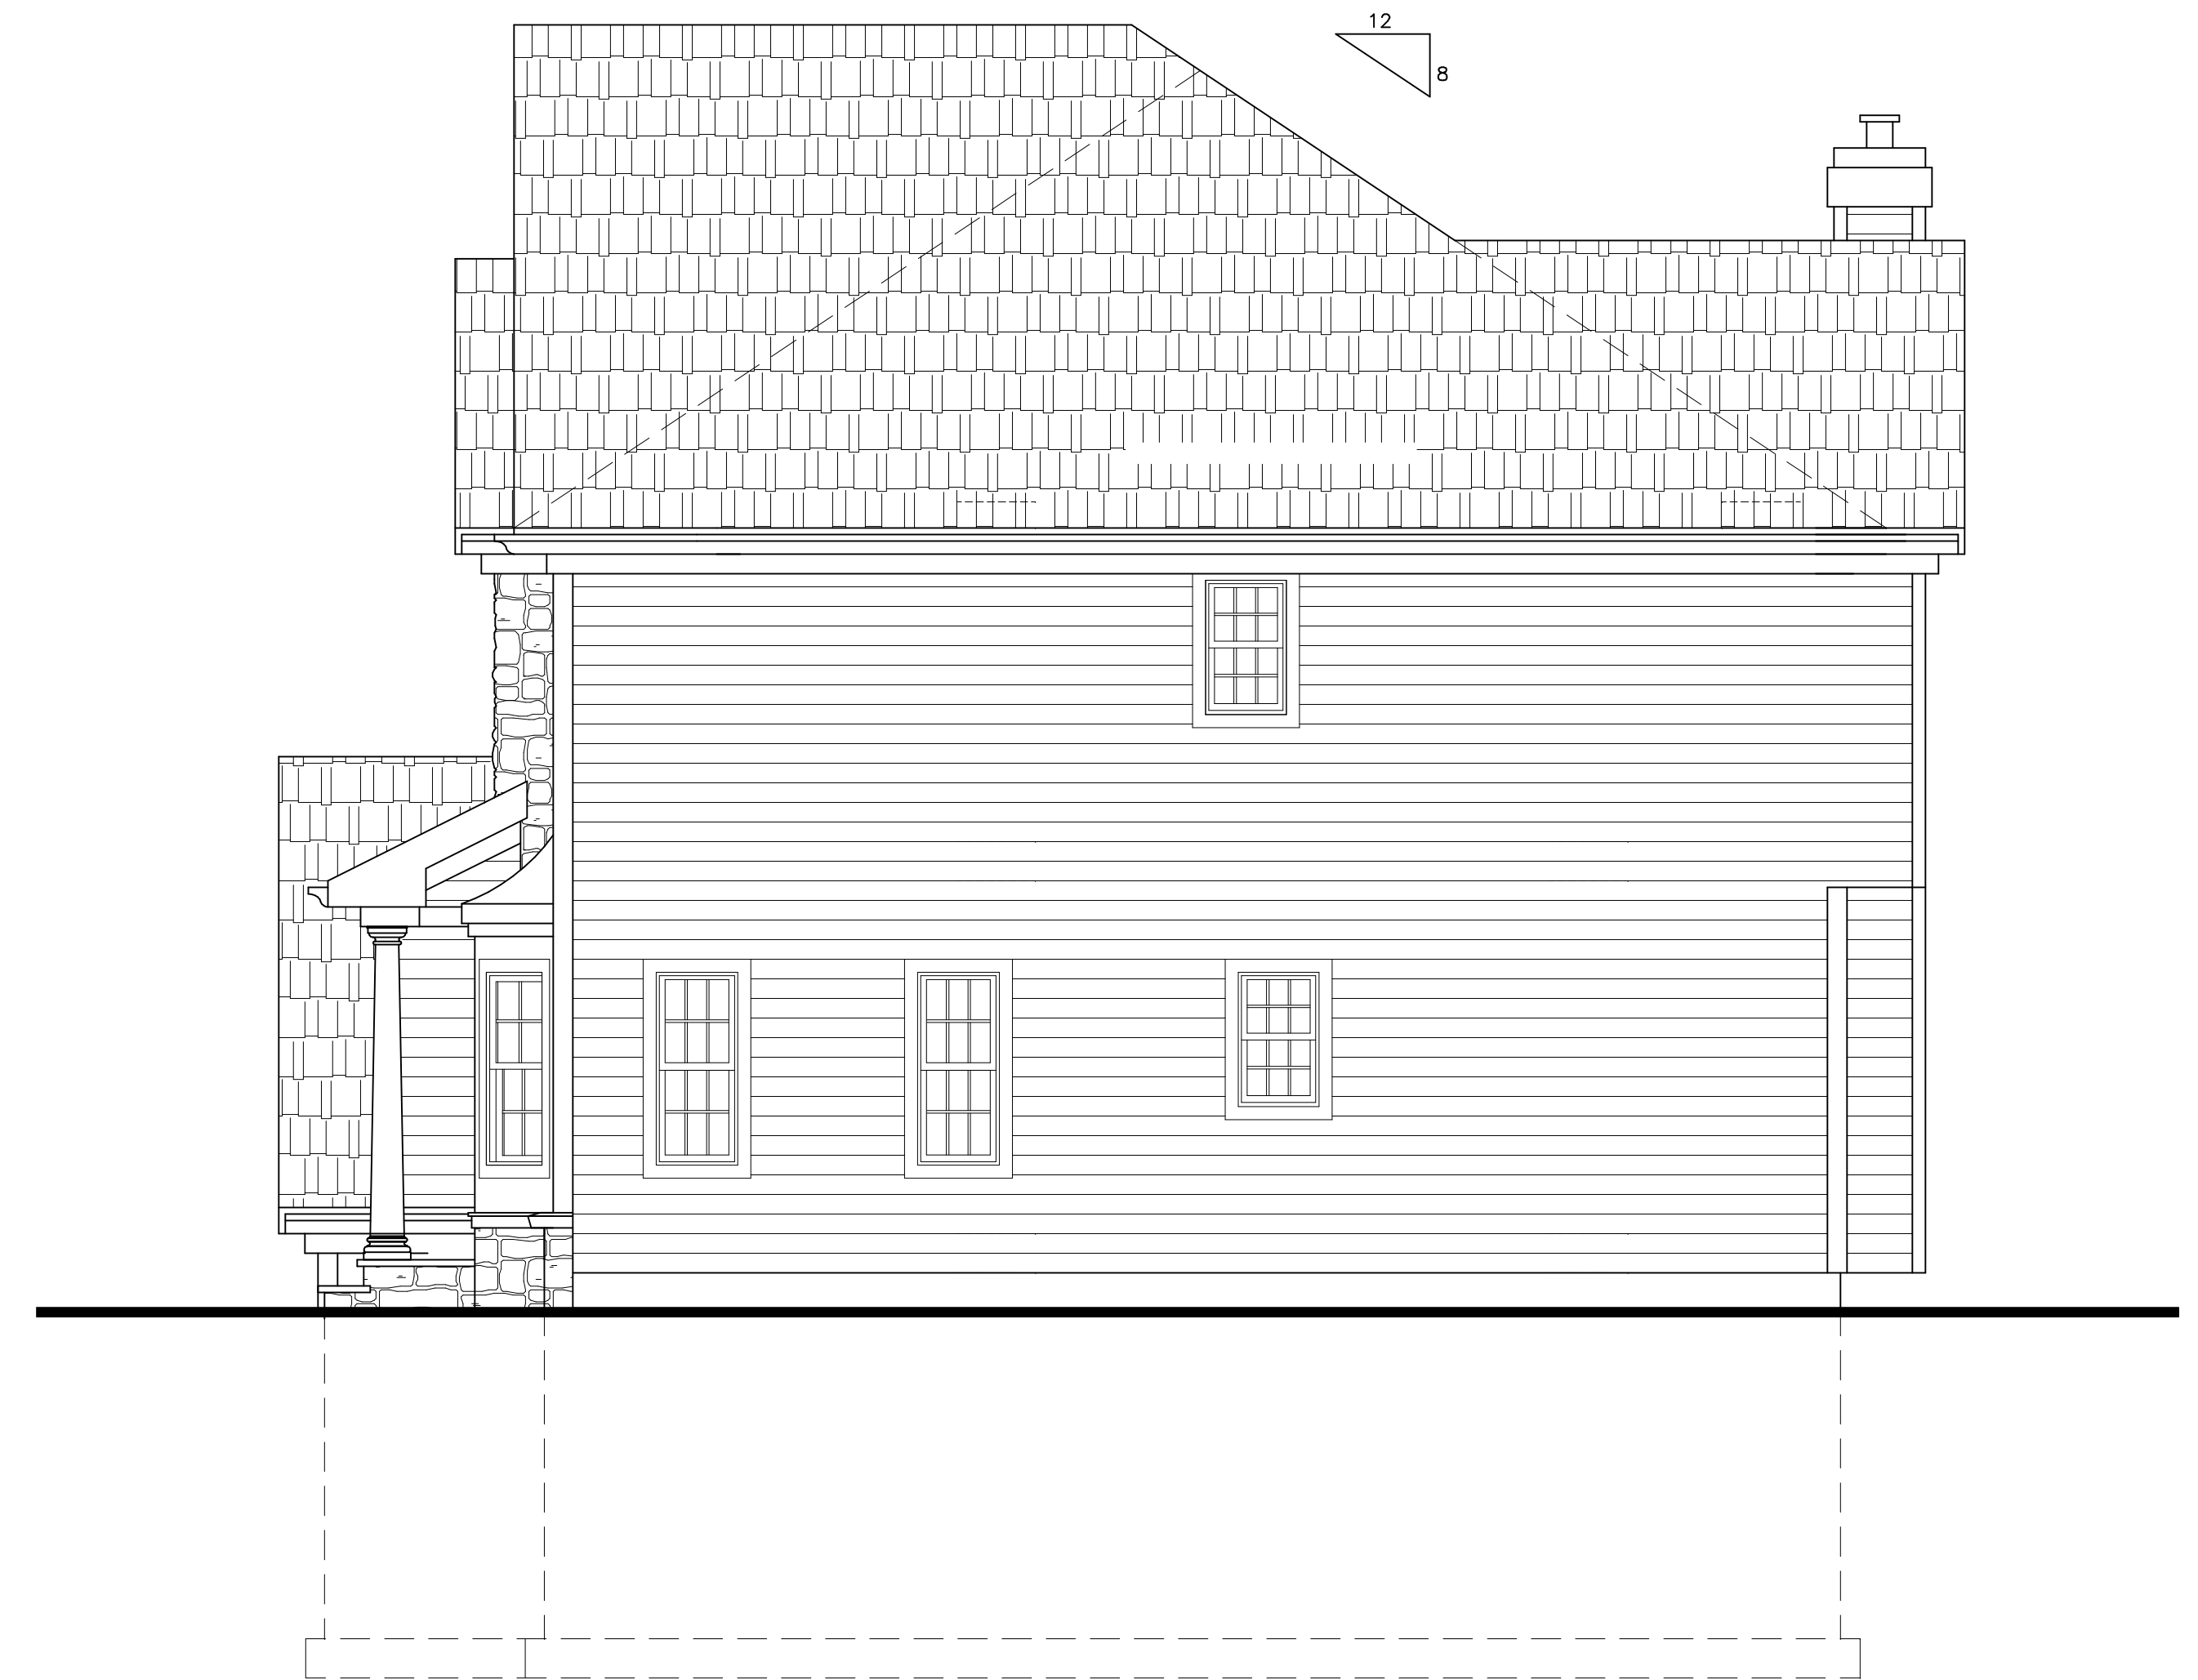


2 RIGHT SIDE ELEVATION  
A-2  
SCALE 1/4"=1'-0"

DATE	REVISIONS	BY
 <p><b>Wellisch Architects LLC. AIA</b>            1020 SPRINGFIELD AVE. SUITE 203 TEL (908) 654-7900            MOUNTAINSIDE, NJ 07092 FAX (908) 654-7112            E-mail: wellischarchitect@gmail.com</p>		
<b>PROJECT</b> <b>SINGLE FAMILY HOUSE</b> JACOB WAY BLOCK 2, LOT # 22.14 LOPATCONG TWP., WARREN COUNTY, NJ NEW CONSTRUCTION "SCENIC RIDGE"		
DRAWING/S REAR AND RIGHT ELEVATIONS		
DATE:	03/11/19	SCALE: AS NOTED
COMM.#	19S13e-6sA-u	DRAWN BY: S.B.
GROUP	- R-5	APPROVED: Y.I.W.
CONST. TYPE	- V-B	
YUVAL WELLISCH ARCH. NJ LIC. AI 14910	SEAL	SHEET NO. A2

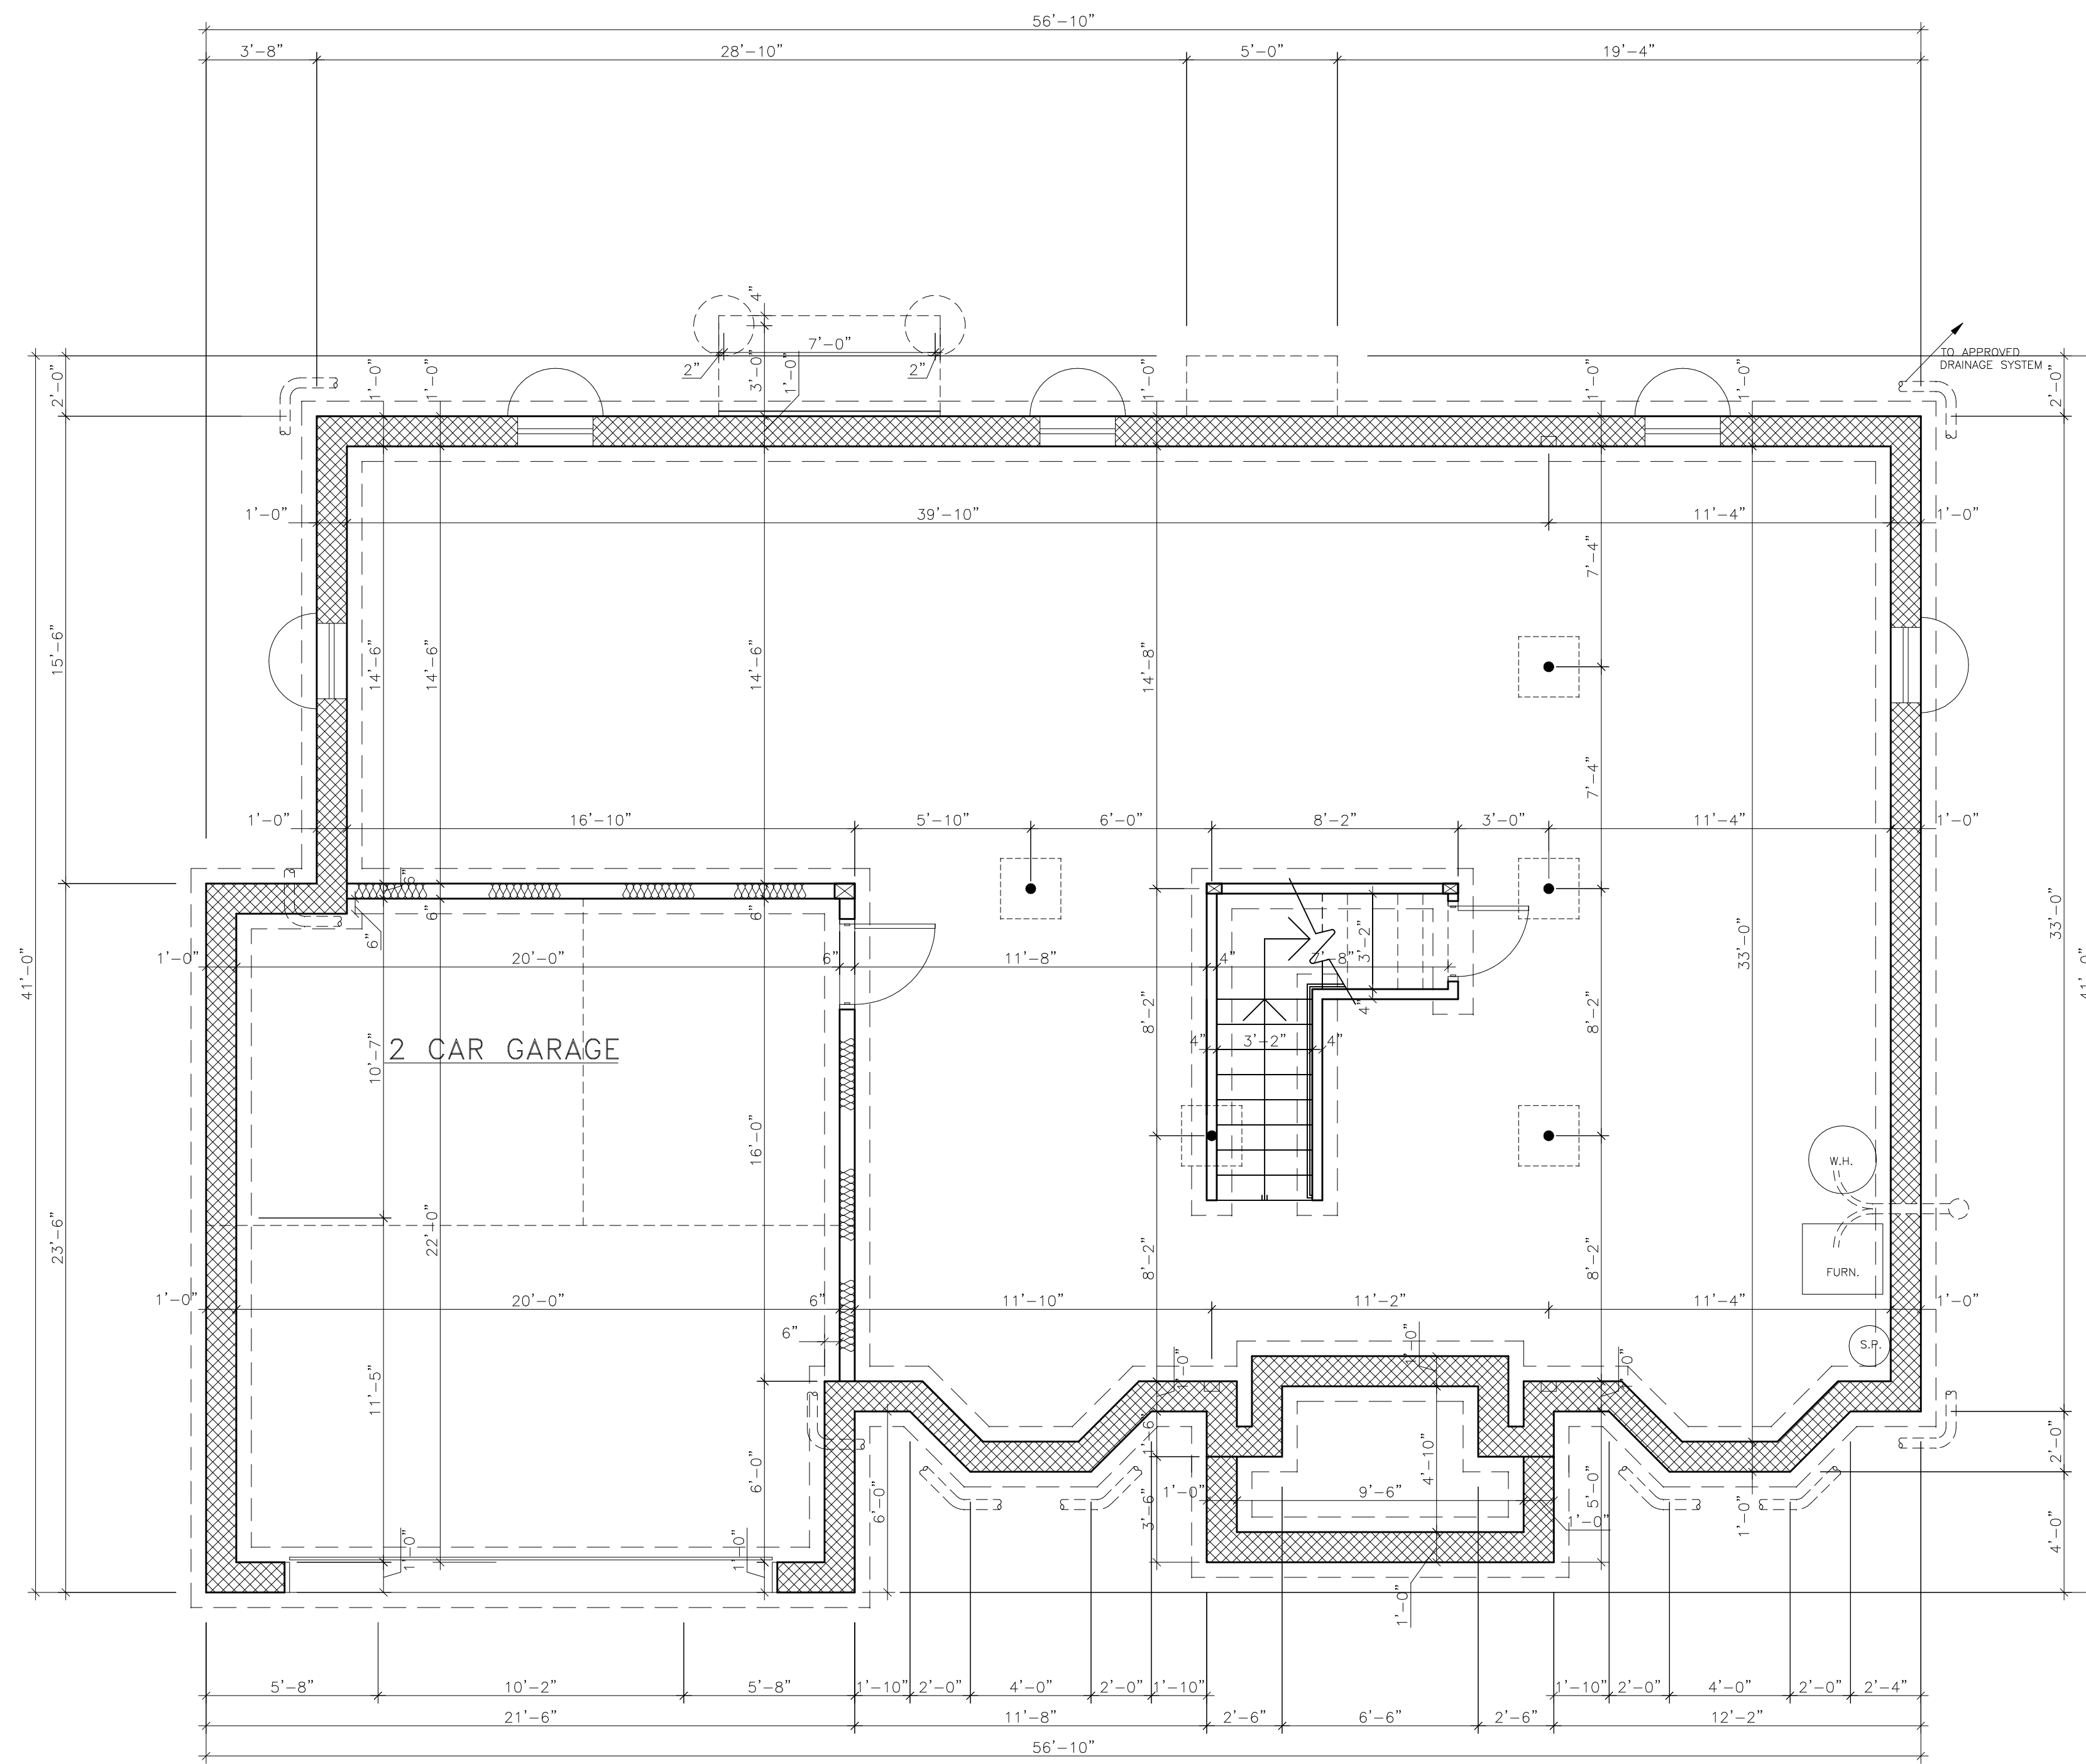


1 BASEMENT/FOUNDATION PLAN  
A-3

SCALE 1/4"=1'-0" AREA - 1485.00 S.F. VOLUME - 13365.00 C.F.

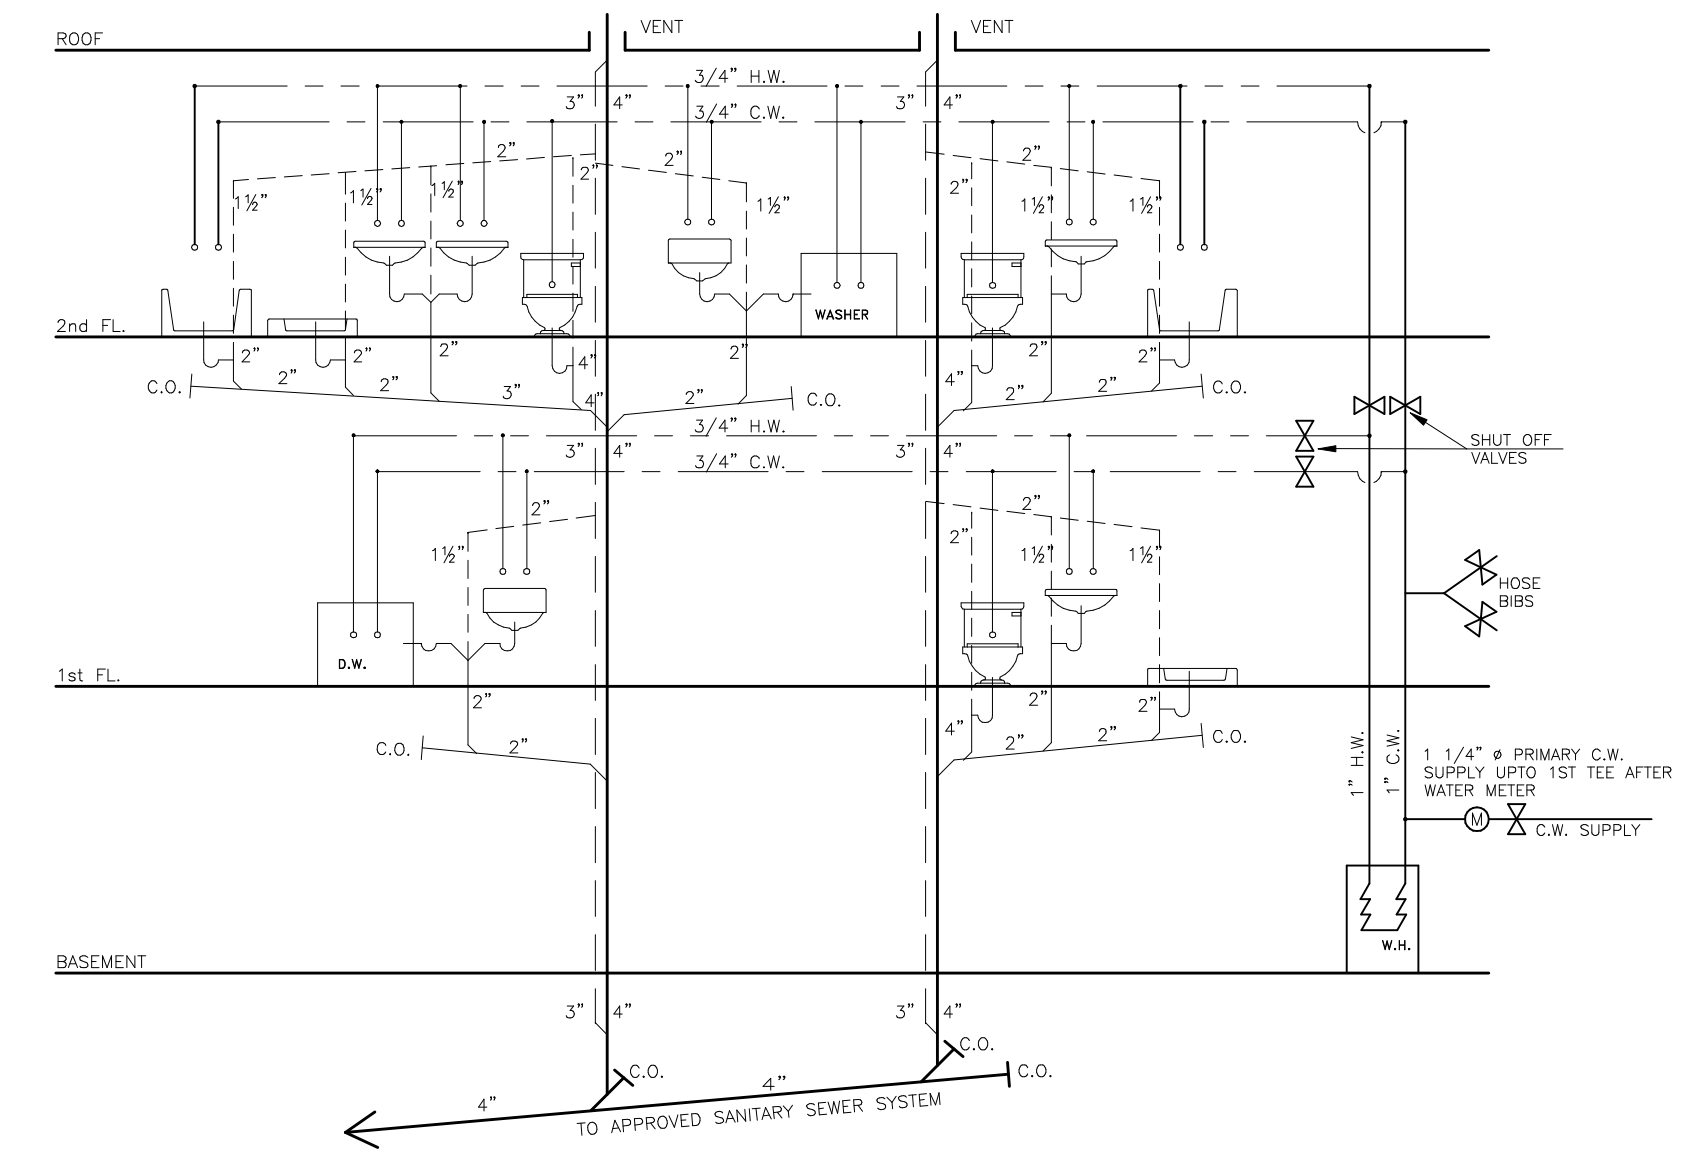

2 PLUMBING RISER DIAGRAM  
A-3

NOT TO SCALE

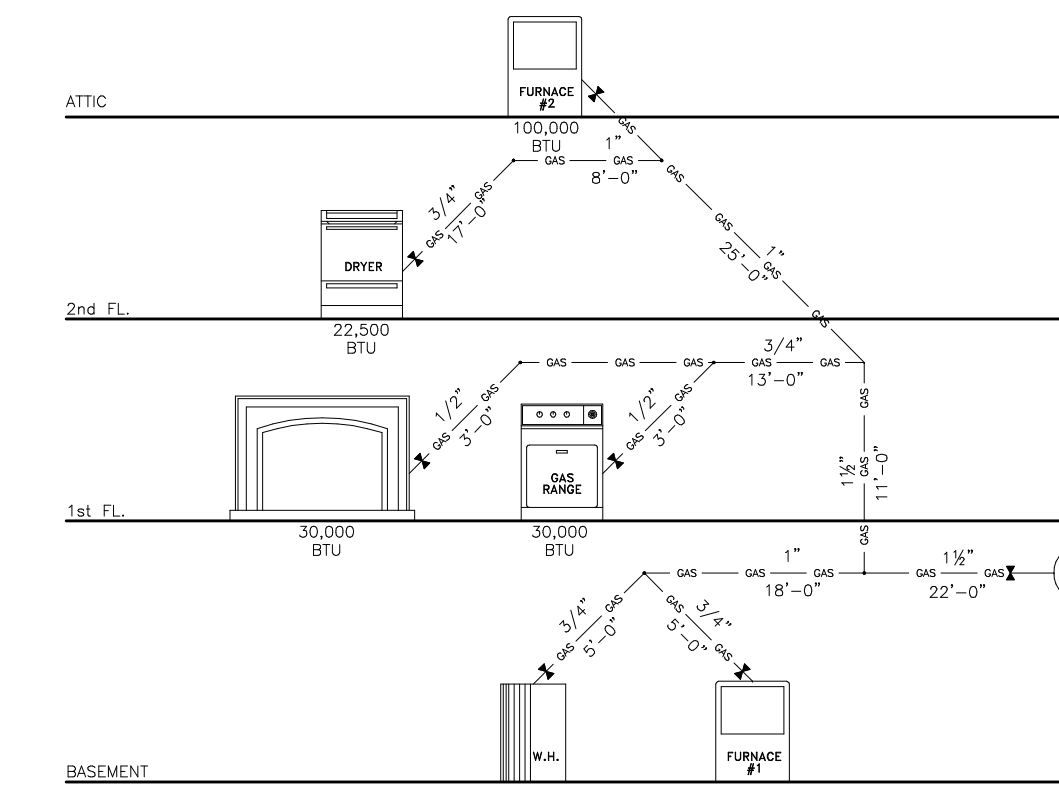

3 GAS RISER DIAGRAM  
A-3

NOT TO SCALE

DATE	REVISIONS	BY
------	-----------	----

**Wellisch Architects LLC. AIA**  
 1020 SPRINGFIELD AVE. SUITE 203 TEL (908) 654-7900  
 MOUNTAINSIDE, NJ 07092 FAX (908) 654-7112  
 E-mail: wellischarchitect@gmail.com

**PROJECT**  
**SINGLE FAMILY HOUSE**  
 JACOB WAY  
 BLOCK 2, LOT # 22.14  
 LOPATCONG TWP.,  
 WARREN COUNTY, NJ  
 NEW CONSTRUCTION "SCENIC RIDGE"

DRAWING/S BASEMENT & FOUNDATION PLAN  
 GAS & PLUMBING RISER DIAGRAM


DATE: 03/11/19 SCALE: AS NOTED

COMM.# 19S13e-6sA-u DRAWN BY: S.B.

GROUP - R-5 APPROVED: Y.I.W.  
 CONST. TYPE - V-B

YUVAL WELLSCH ARCH. SEAL SHEET NO.  
 NJ LIC. AI 14910

A3

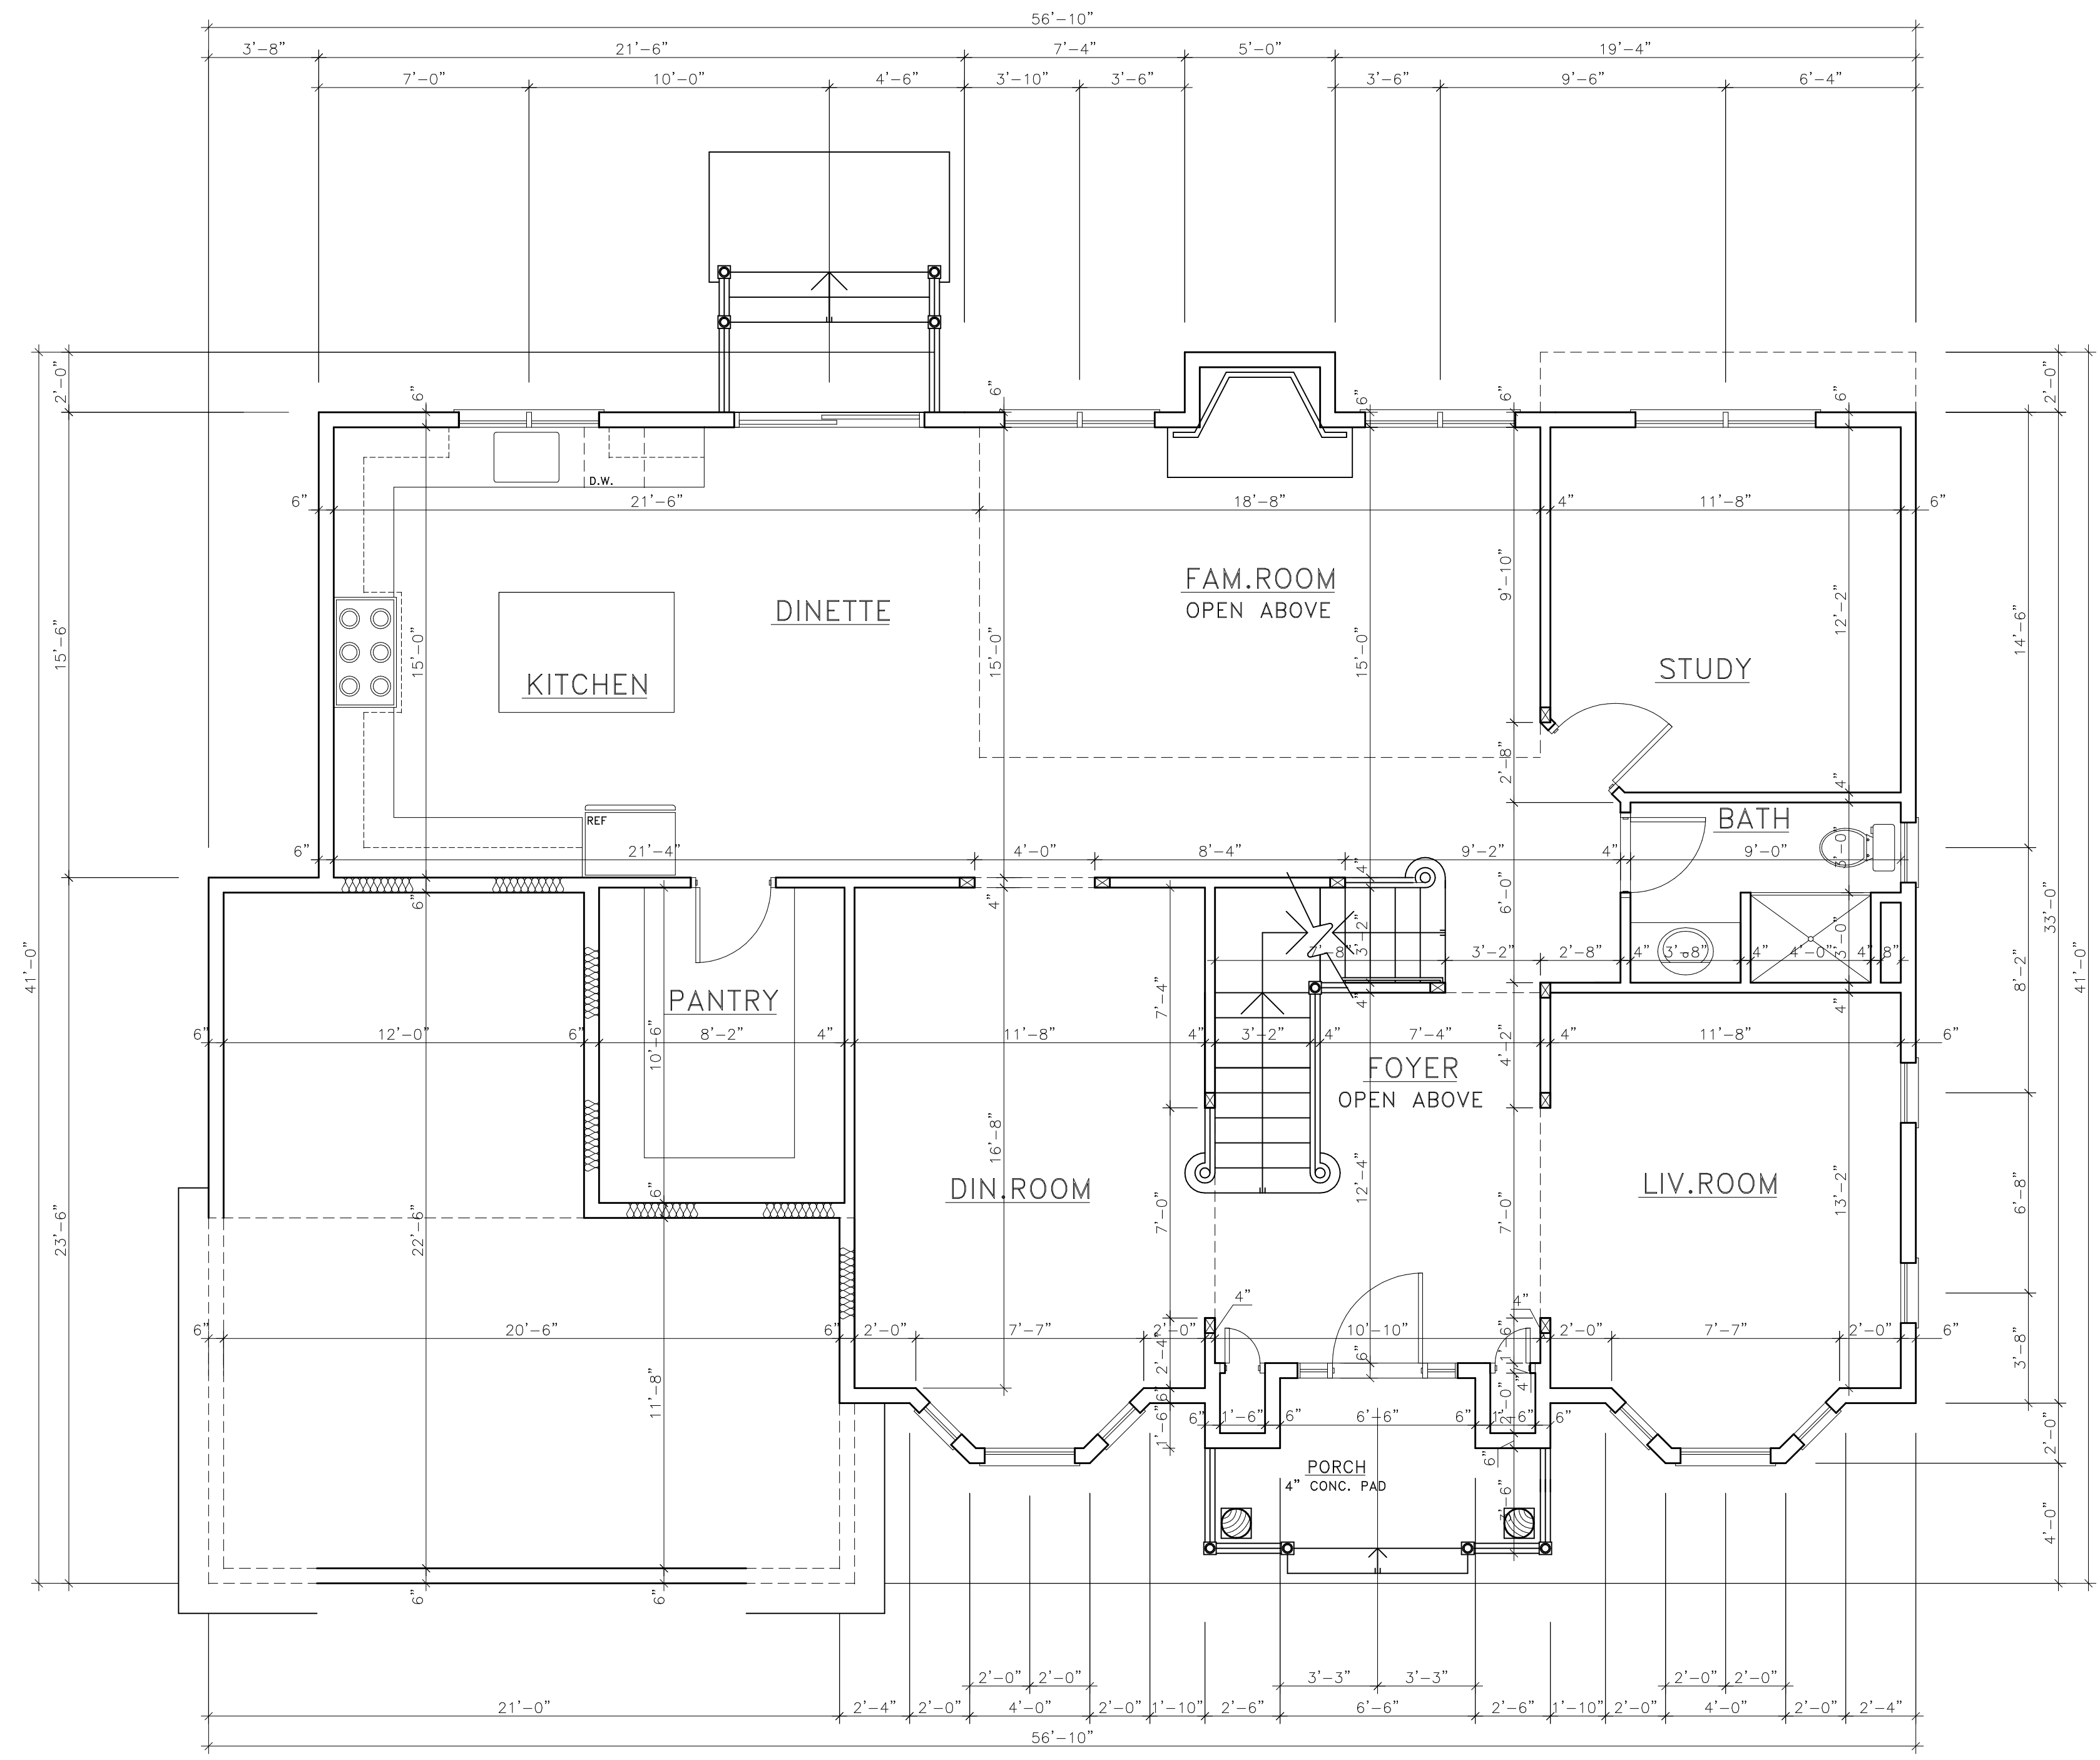

1 FIRST FLOOR PLAN  
 A-4  
 SCALE 1/4"=1'-0" AREA - 1577.00 S.F. VOLUME - 15770.00 C.F.

DATE	REVISIONS	BY

**Wellisch Architects LLC. AIA**  
 1020 SPRINGFIELD AVE. SUITE 203 TEL (908) 654-7900  
 MOUNTAINSIDE, NJ 07092 FAX (908) 654-7112  
 E-mail: wellischarchitect@gmail.com

**PROJECT**  
**SINGLE FAMILY HOUSE**  
 JACOB WAY  
 BLOCK 2, LOT # 22.14  
 LOPATCONG TWP.,  
 WARREN COUNTY, NJ  
 NEW CONSTRUCTION "SCENIC RIDGE"


DRAWING/S FIRST FLOOR PLAN

DATE: 03/11/19	SCALE: AS NOTED
----------------	-----------------

COMM.# 19S13e-6sA-u	DRAWN BY: S.B.
---------------------	----------------


GROUP - R-5	APPROVED: Y.I.W.
CONST. TYPE - V-B	

YUVAL WELLISCH ARCH. NJ LIC. AI 14910	SEAL	SHEET NO. A4
--	------	-----------------

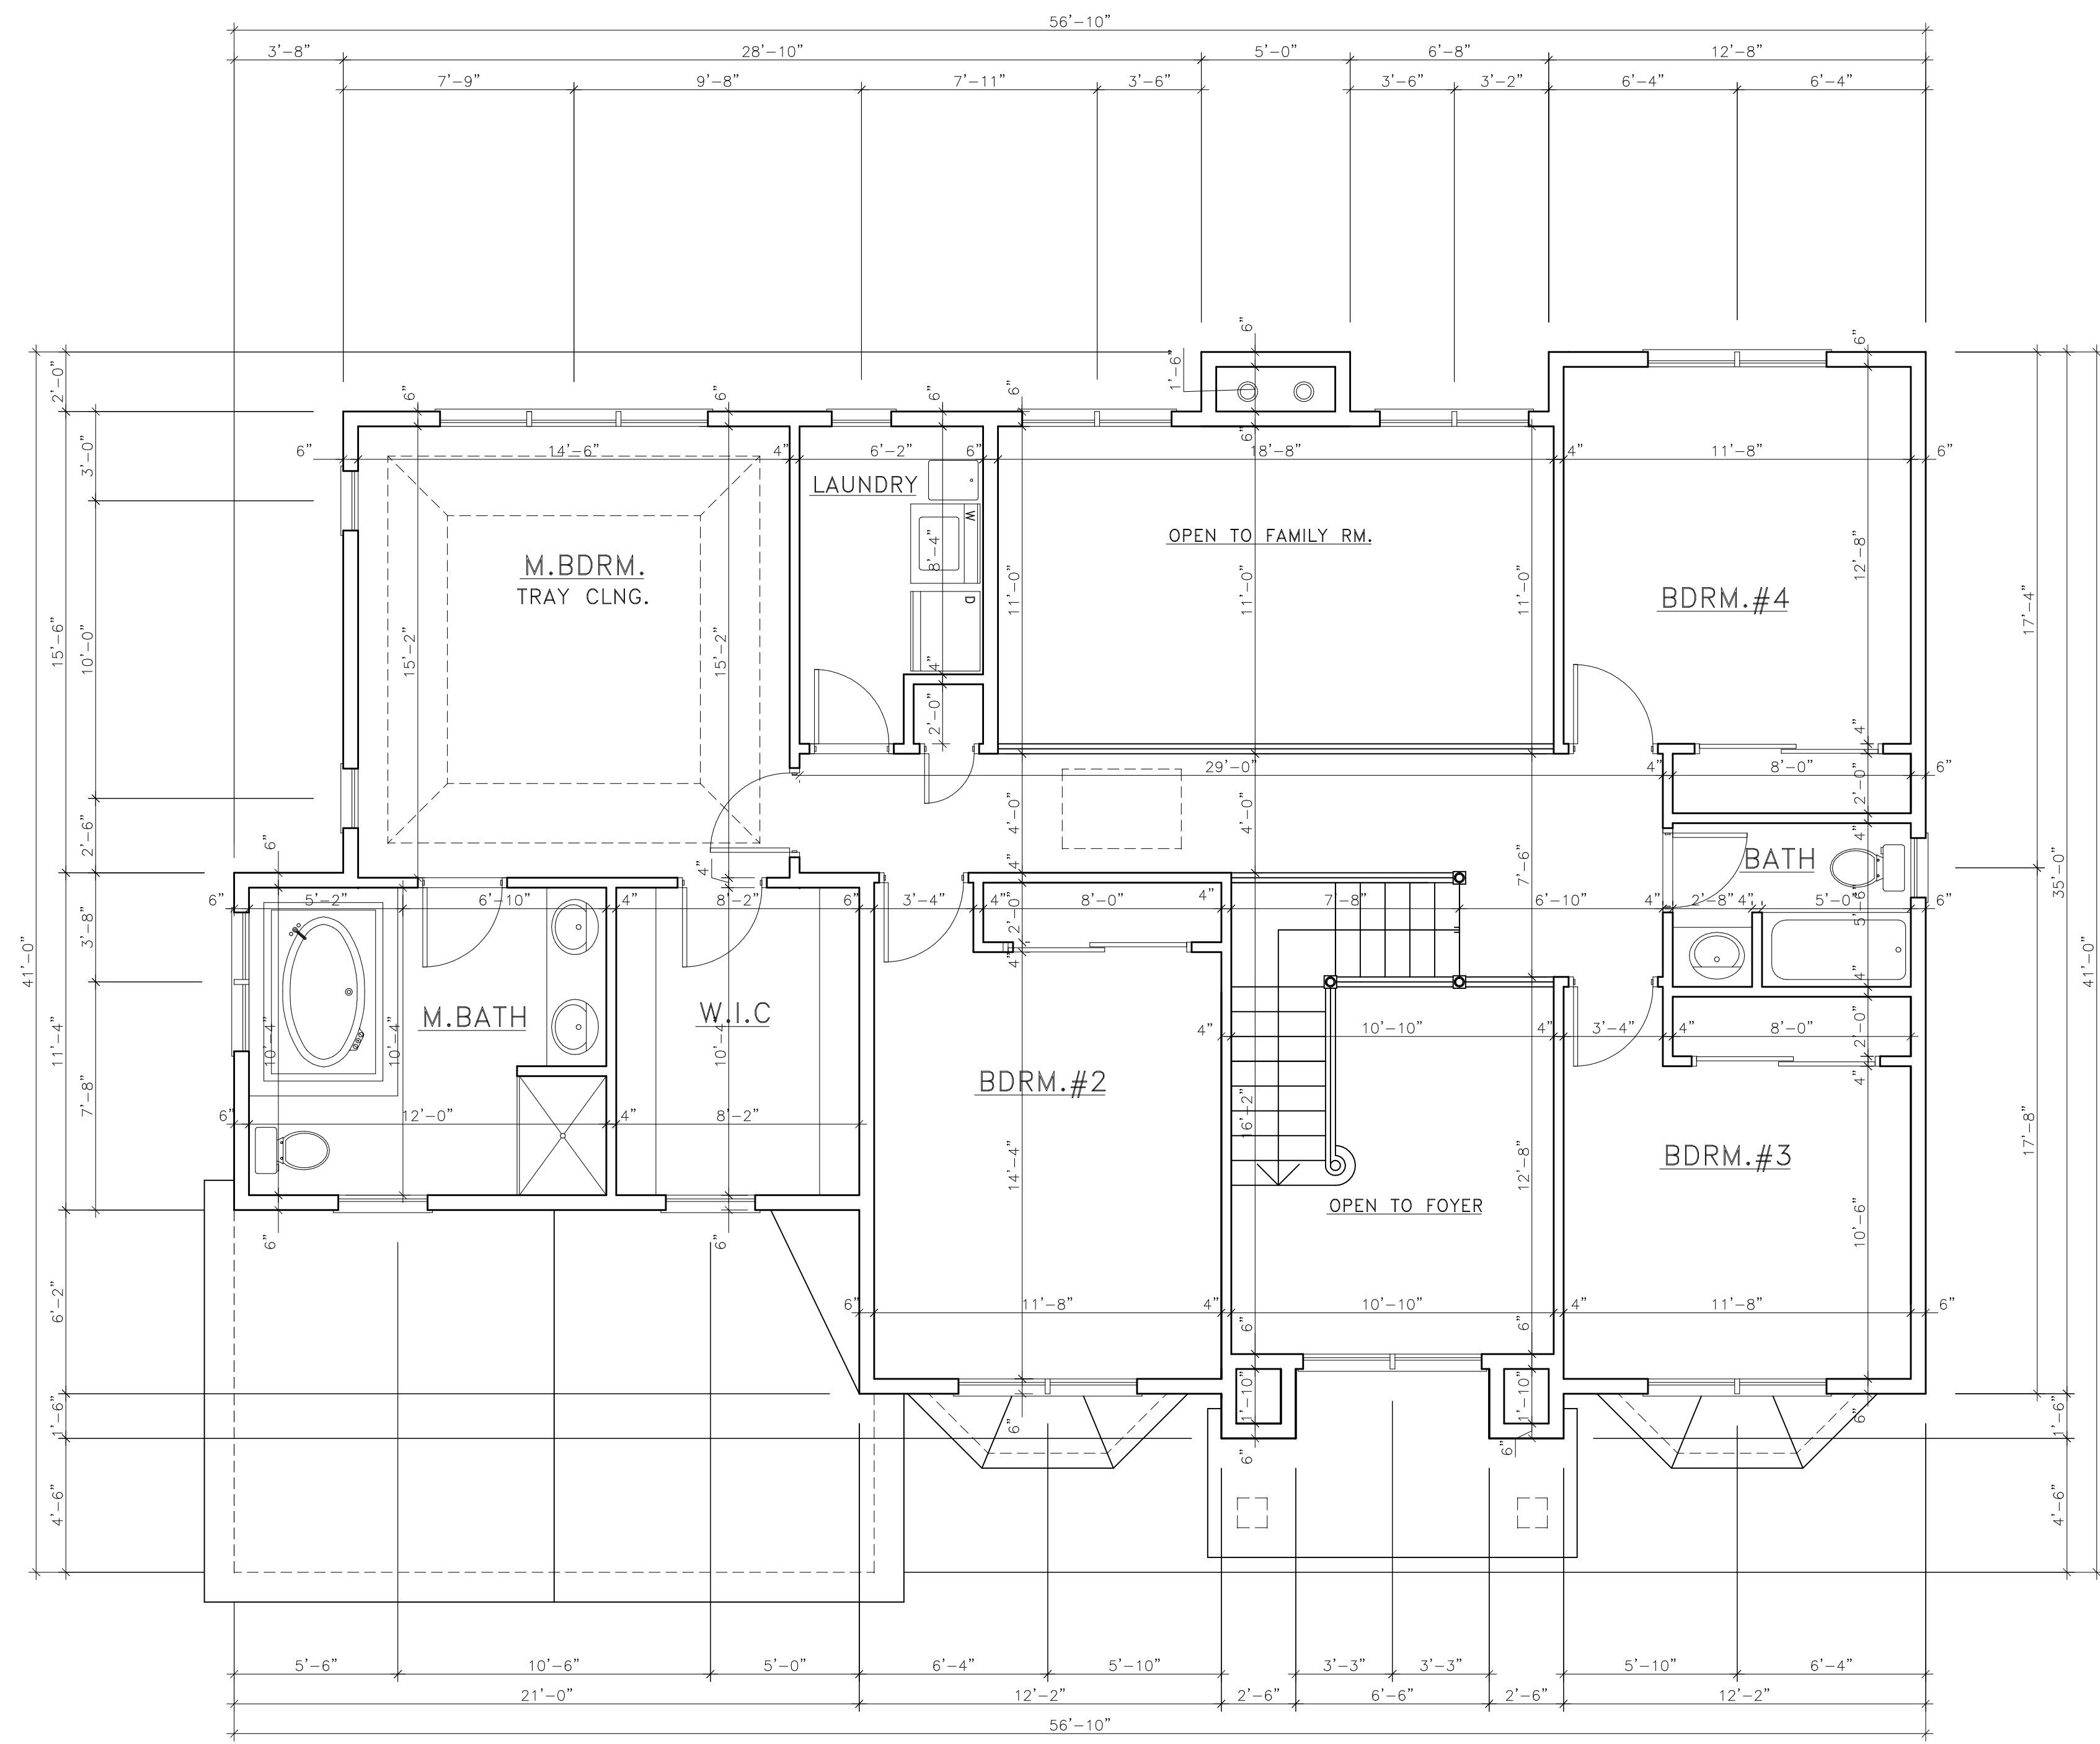

1 SECOND FLOOR PLAN  
A-5

SCALE 1/4"=1'-0" AREA - 1323.00 S.F. VOLUME - 10584.00 C.F.

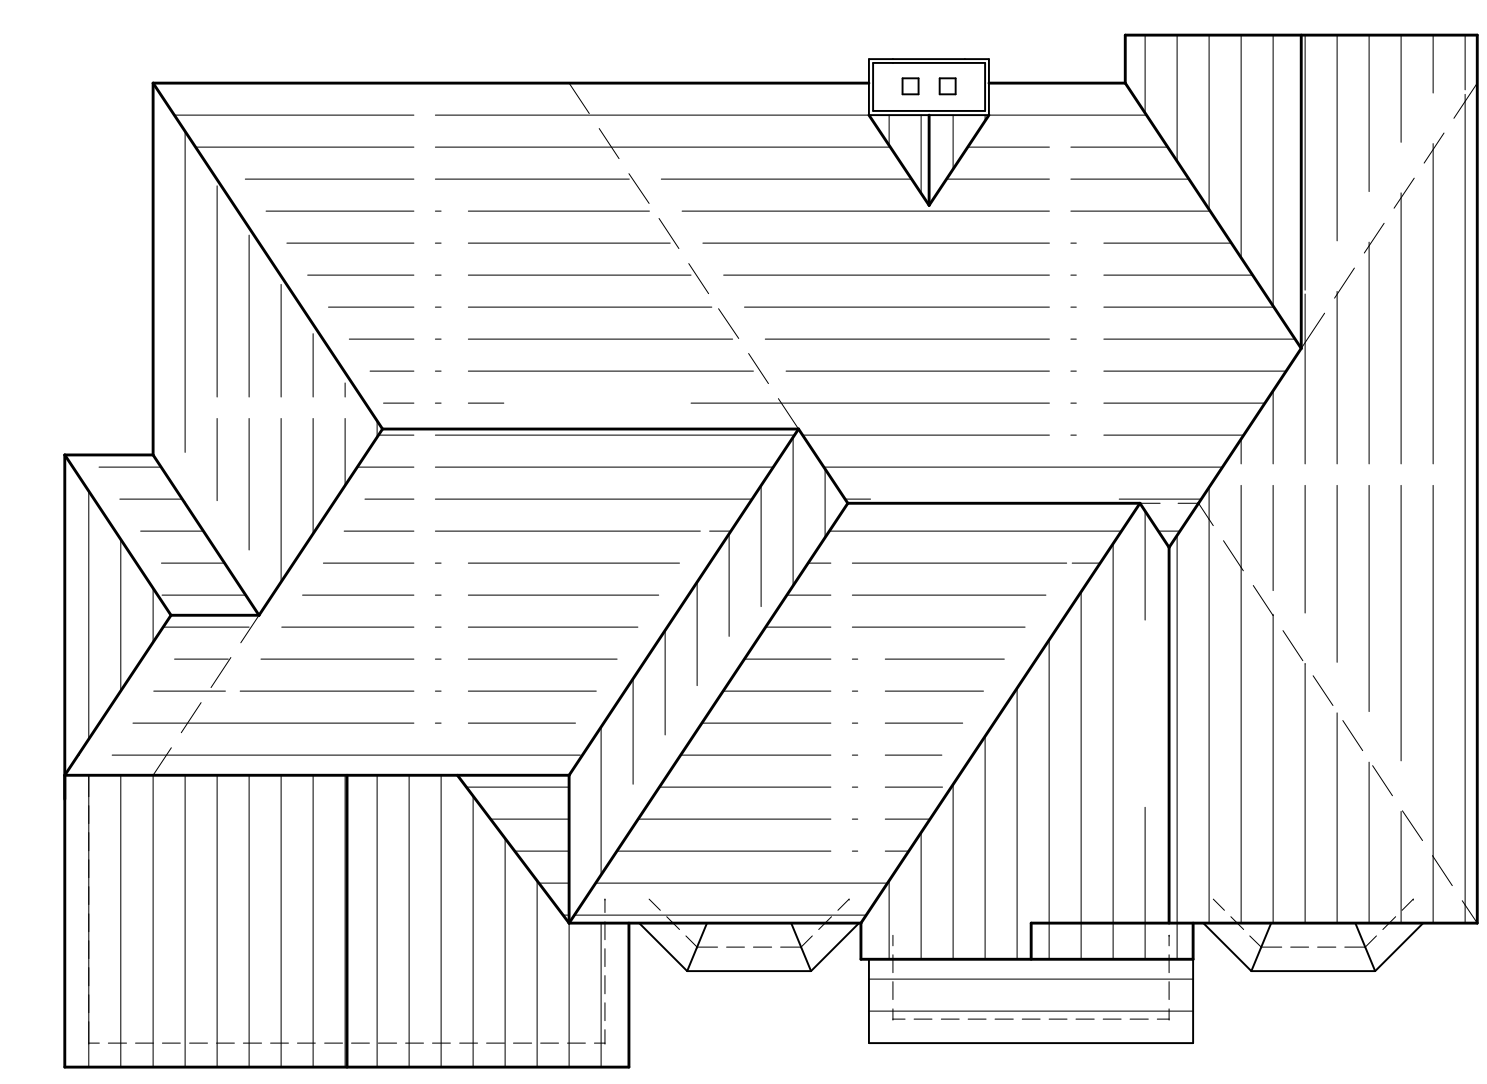

2 ROOF PLAN  
A-5  
SCALE 1/8"=1'-0"

DATE	REVISIONS	BY

**Wellisch Architects LLC. AIA**  
 1020 SPRINGFIELD AVE. SUITE 203 TEL (908) 654-7900  
 MOUNTAINSIDE, NJ 07092 FAX (908) 654-7112  
 E-mail: wellischarchitect@gmail.com

**PROJECT**  
**SINGLE FAMILY HOUSE**  
 JACOB WAY  
 BLOCK 2, LOT # 22.14  
 LOPATCONG TWP.,  
 WARREN COUNTY, NJ  
 NEW CONSTRUCTION "SCENIC RIDGE"

DRAWING/S SECOND FLOOR PLAN ROOF PLAN	
DATE: 03/11/19	SCALE: AS NOTED
COMM.# 19S13e-6sA-u	DRAWN BY: S.B.
GROUP - R-5 CONST. TYPE - V-B	APPROVED: Y.I.W.
YUVAL WELLISCH ARCH. NJ LIC. AI 14910	SEAL
SHEET NO. <b>A5</b>	